


DRAINAGE PLAN LOWER CRAGMOR STORM SEWER

PHASE IV

FOR THE
CITY OF COLORADO SPRINGS
APRIL, 1976

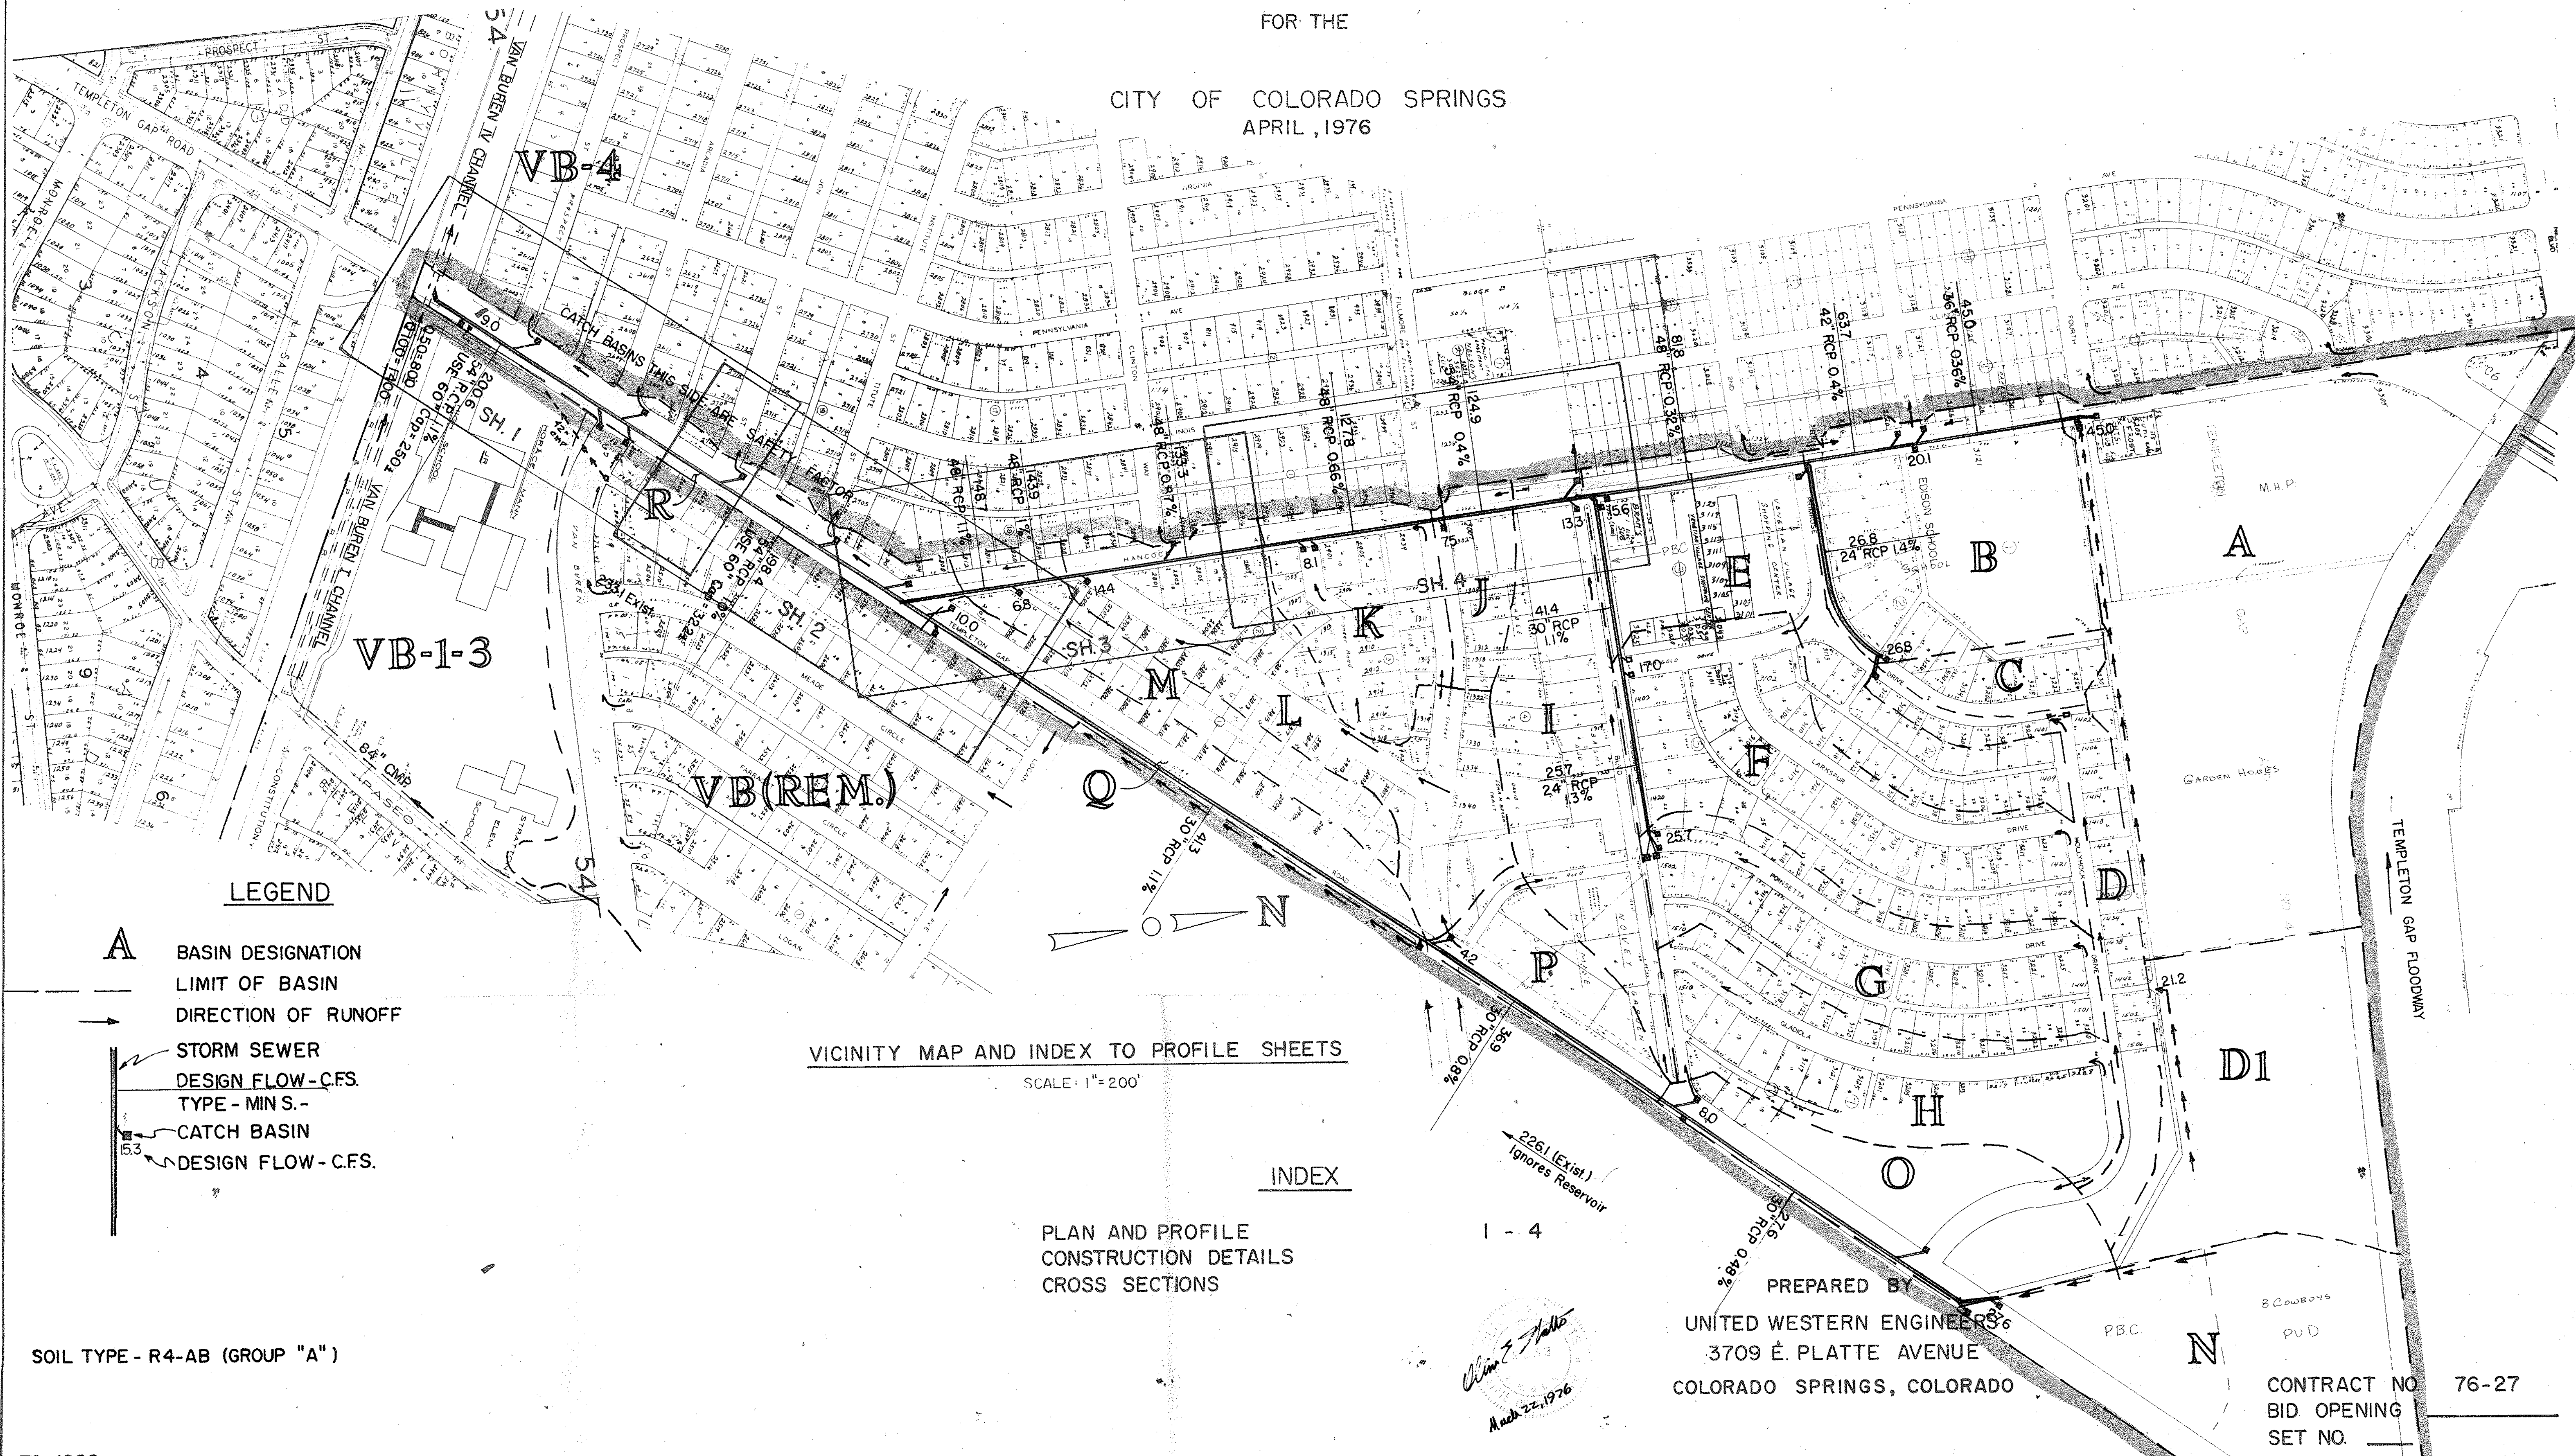

LEGEND

- A** BASIN DESIGNATION
- LIMIT OF BASIN
- DIRECTION OF RUNOFF
- STORM SEWER
- DESIGN FLOW - C.F.S.
- TYPE - MIN S.-
- CATCH BASIN
- DESIGN FLOW - C.F.S.

VICINITY MAP AND INDEX TO PROFILE SHEETS

SCALE: 1" = 200'

INDEX

PLAN AND PROFILE
CONSTRUCTION DETAILS
CROSS SECTIONS

1 - 4

PREPARED BY
UNITED WESTERN ENGINEERS,
3709 E. PLATTE AVENUE
COLORADO SPRINGS, COLORADO

82 COWBOYS
PUD

CONTRACT NO. 76-27
BID OPENING SET NO.

SOIL TYPE - R4-AB (GROUP "A")

Cliff E. Hall
Arch. 23, 1976