


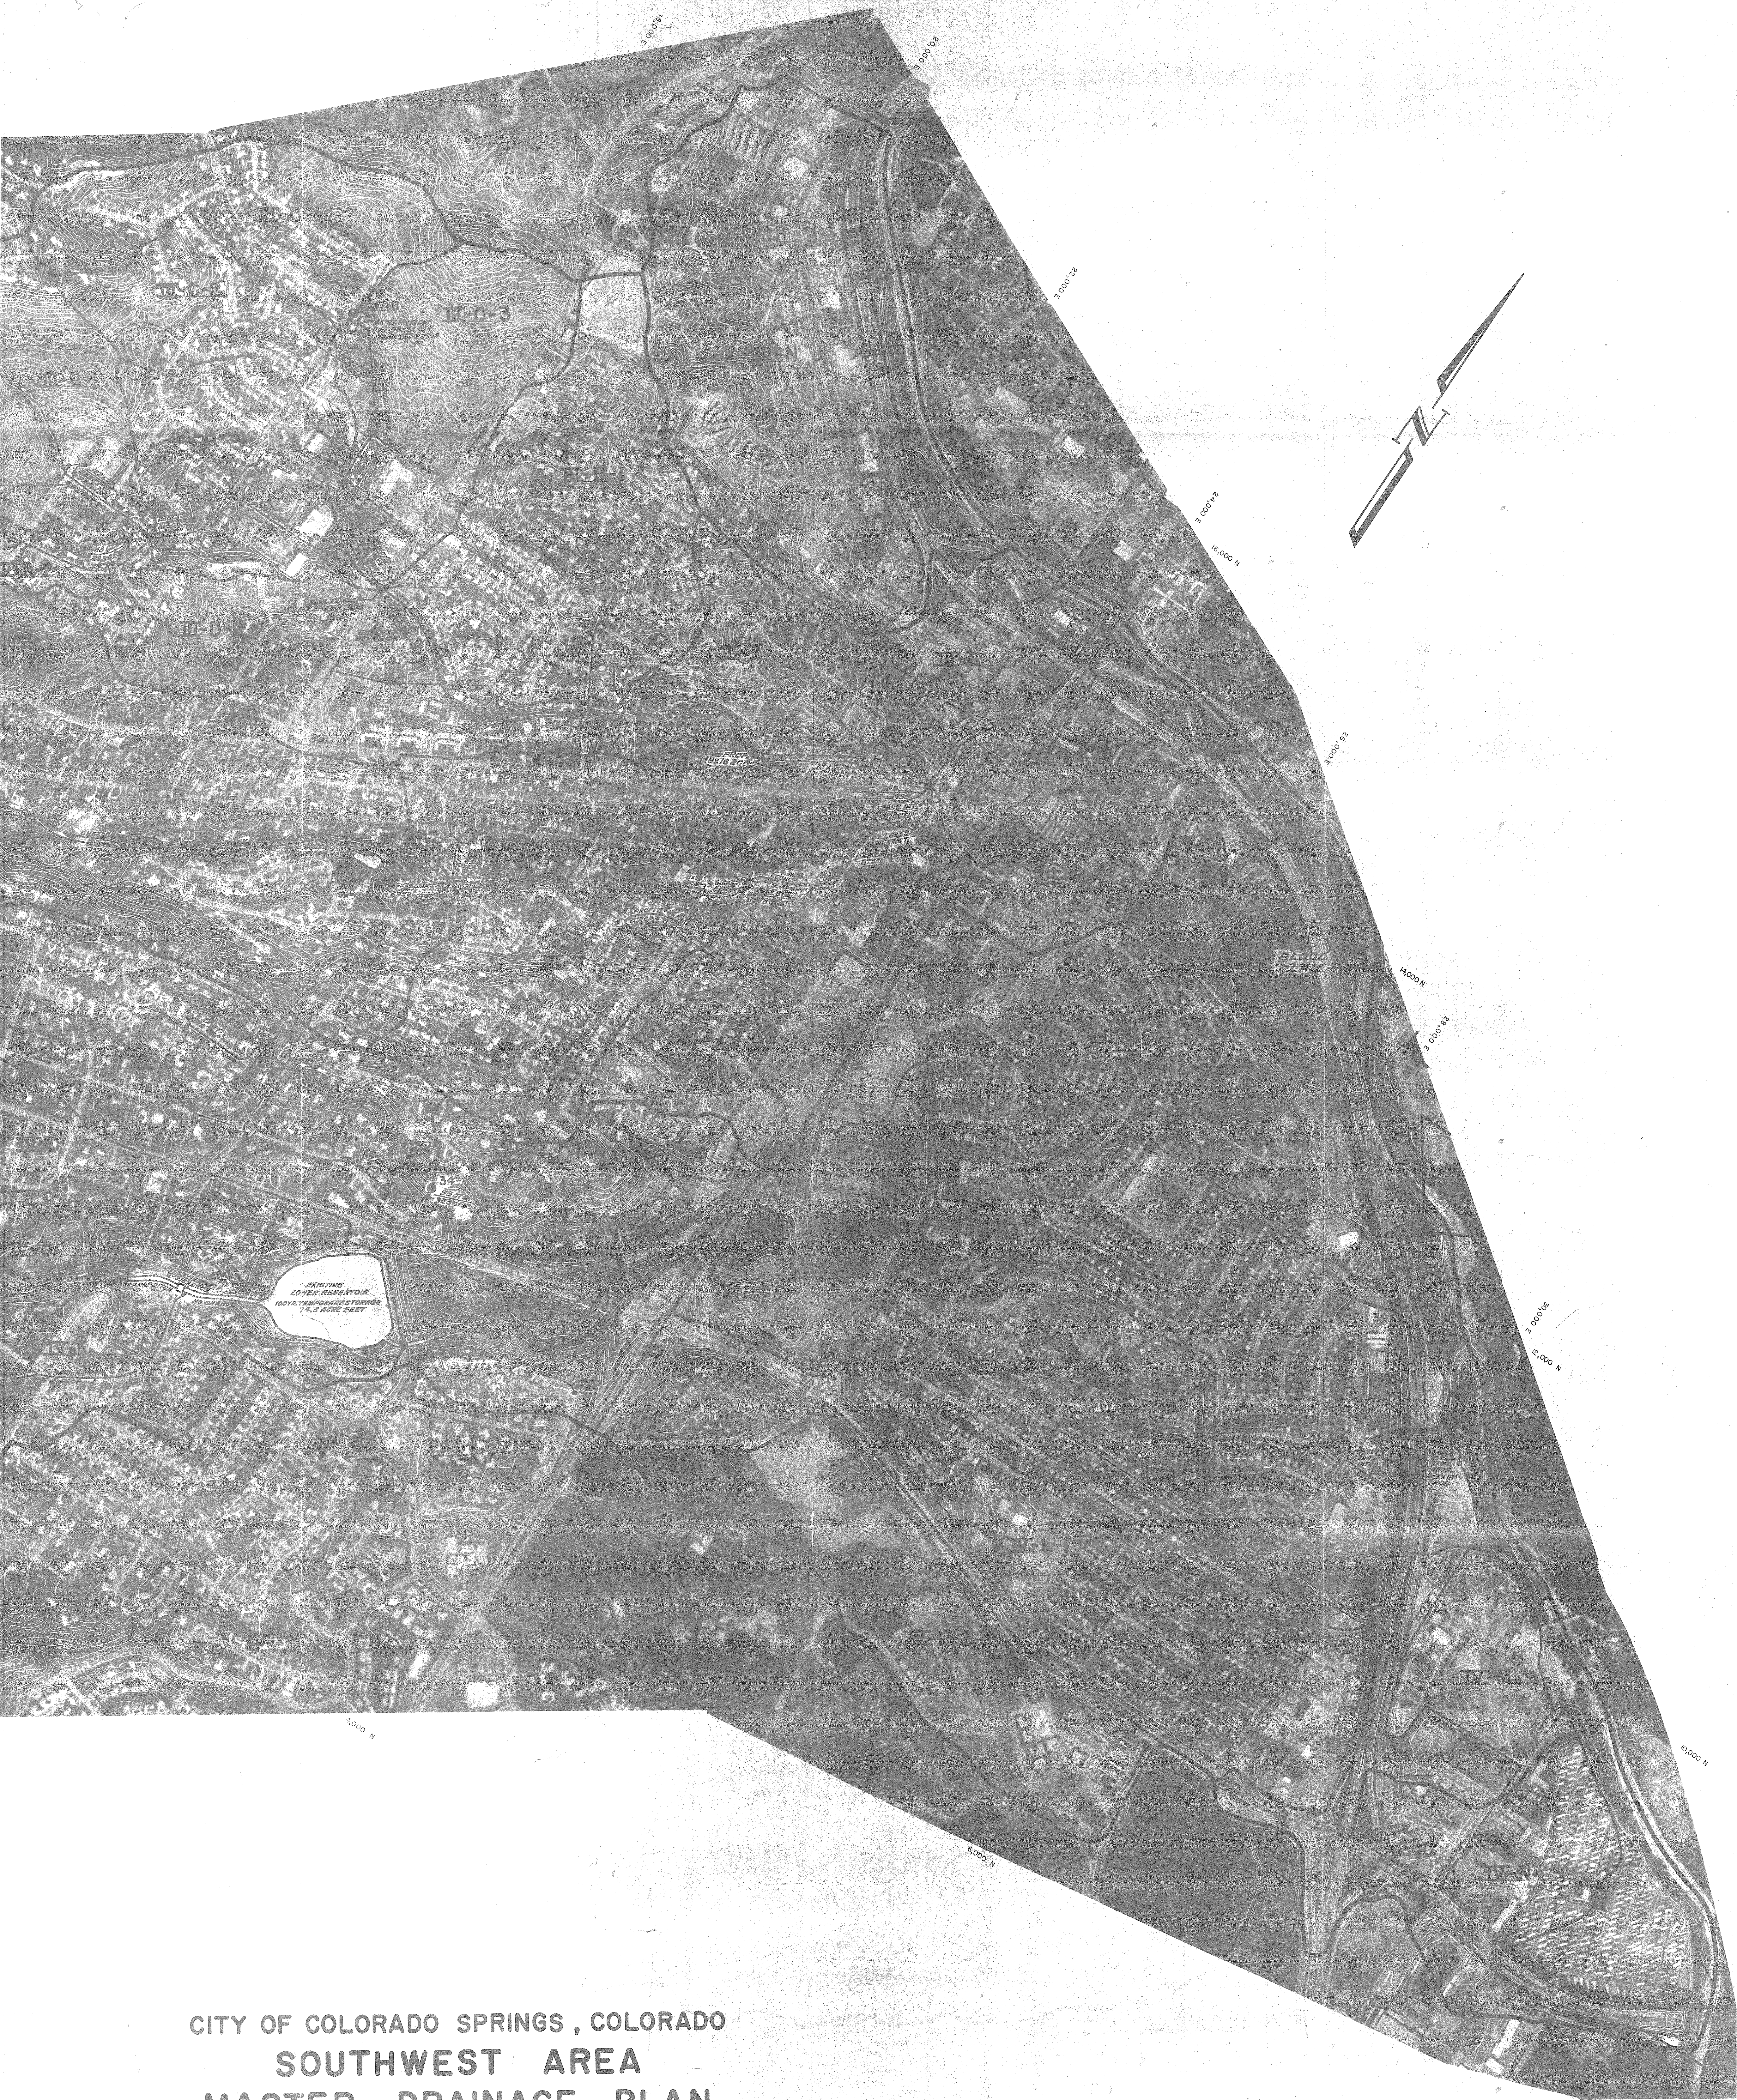

CITY OF COLORADO SPRINGS, COLORADO
SOUTHWEST AREA
MASTER DRAINAGE PLAN
(CHEYENNE RUN, CHEYENNE CREEK, SPRING RUN)

D LINCOLN
DEVORE
ENGINEERS
GEOLOGISTS
COLORADO: Colorado Springs,
Grand Junction, Pueblo,
Glenwood Spgs., WYO. Evanston
DRAWN BY: HMB
CHECKED BY: GDM
SCALE: 1" = 400'
DATE: DEC. 1983
CONT. INTERVAL: 2 FT.
REVISED: