
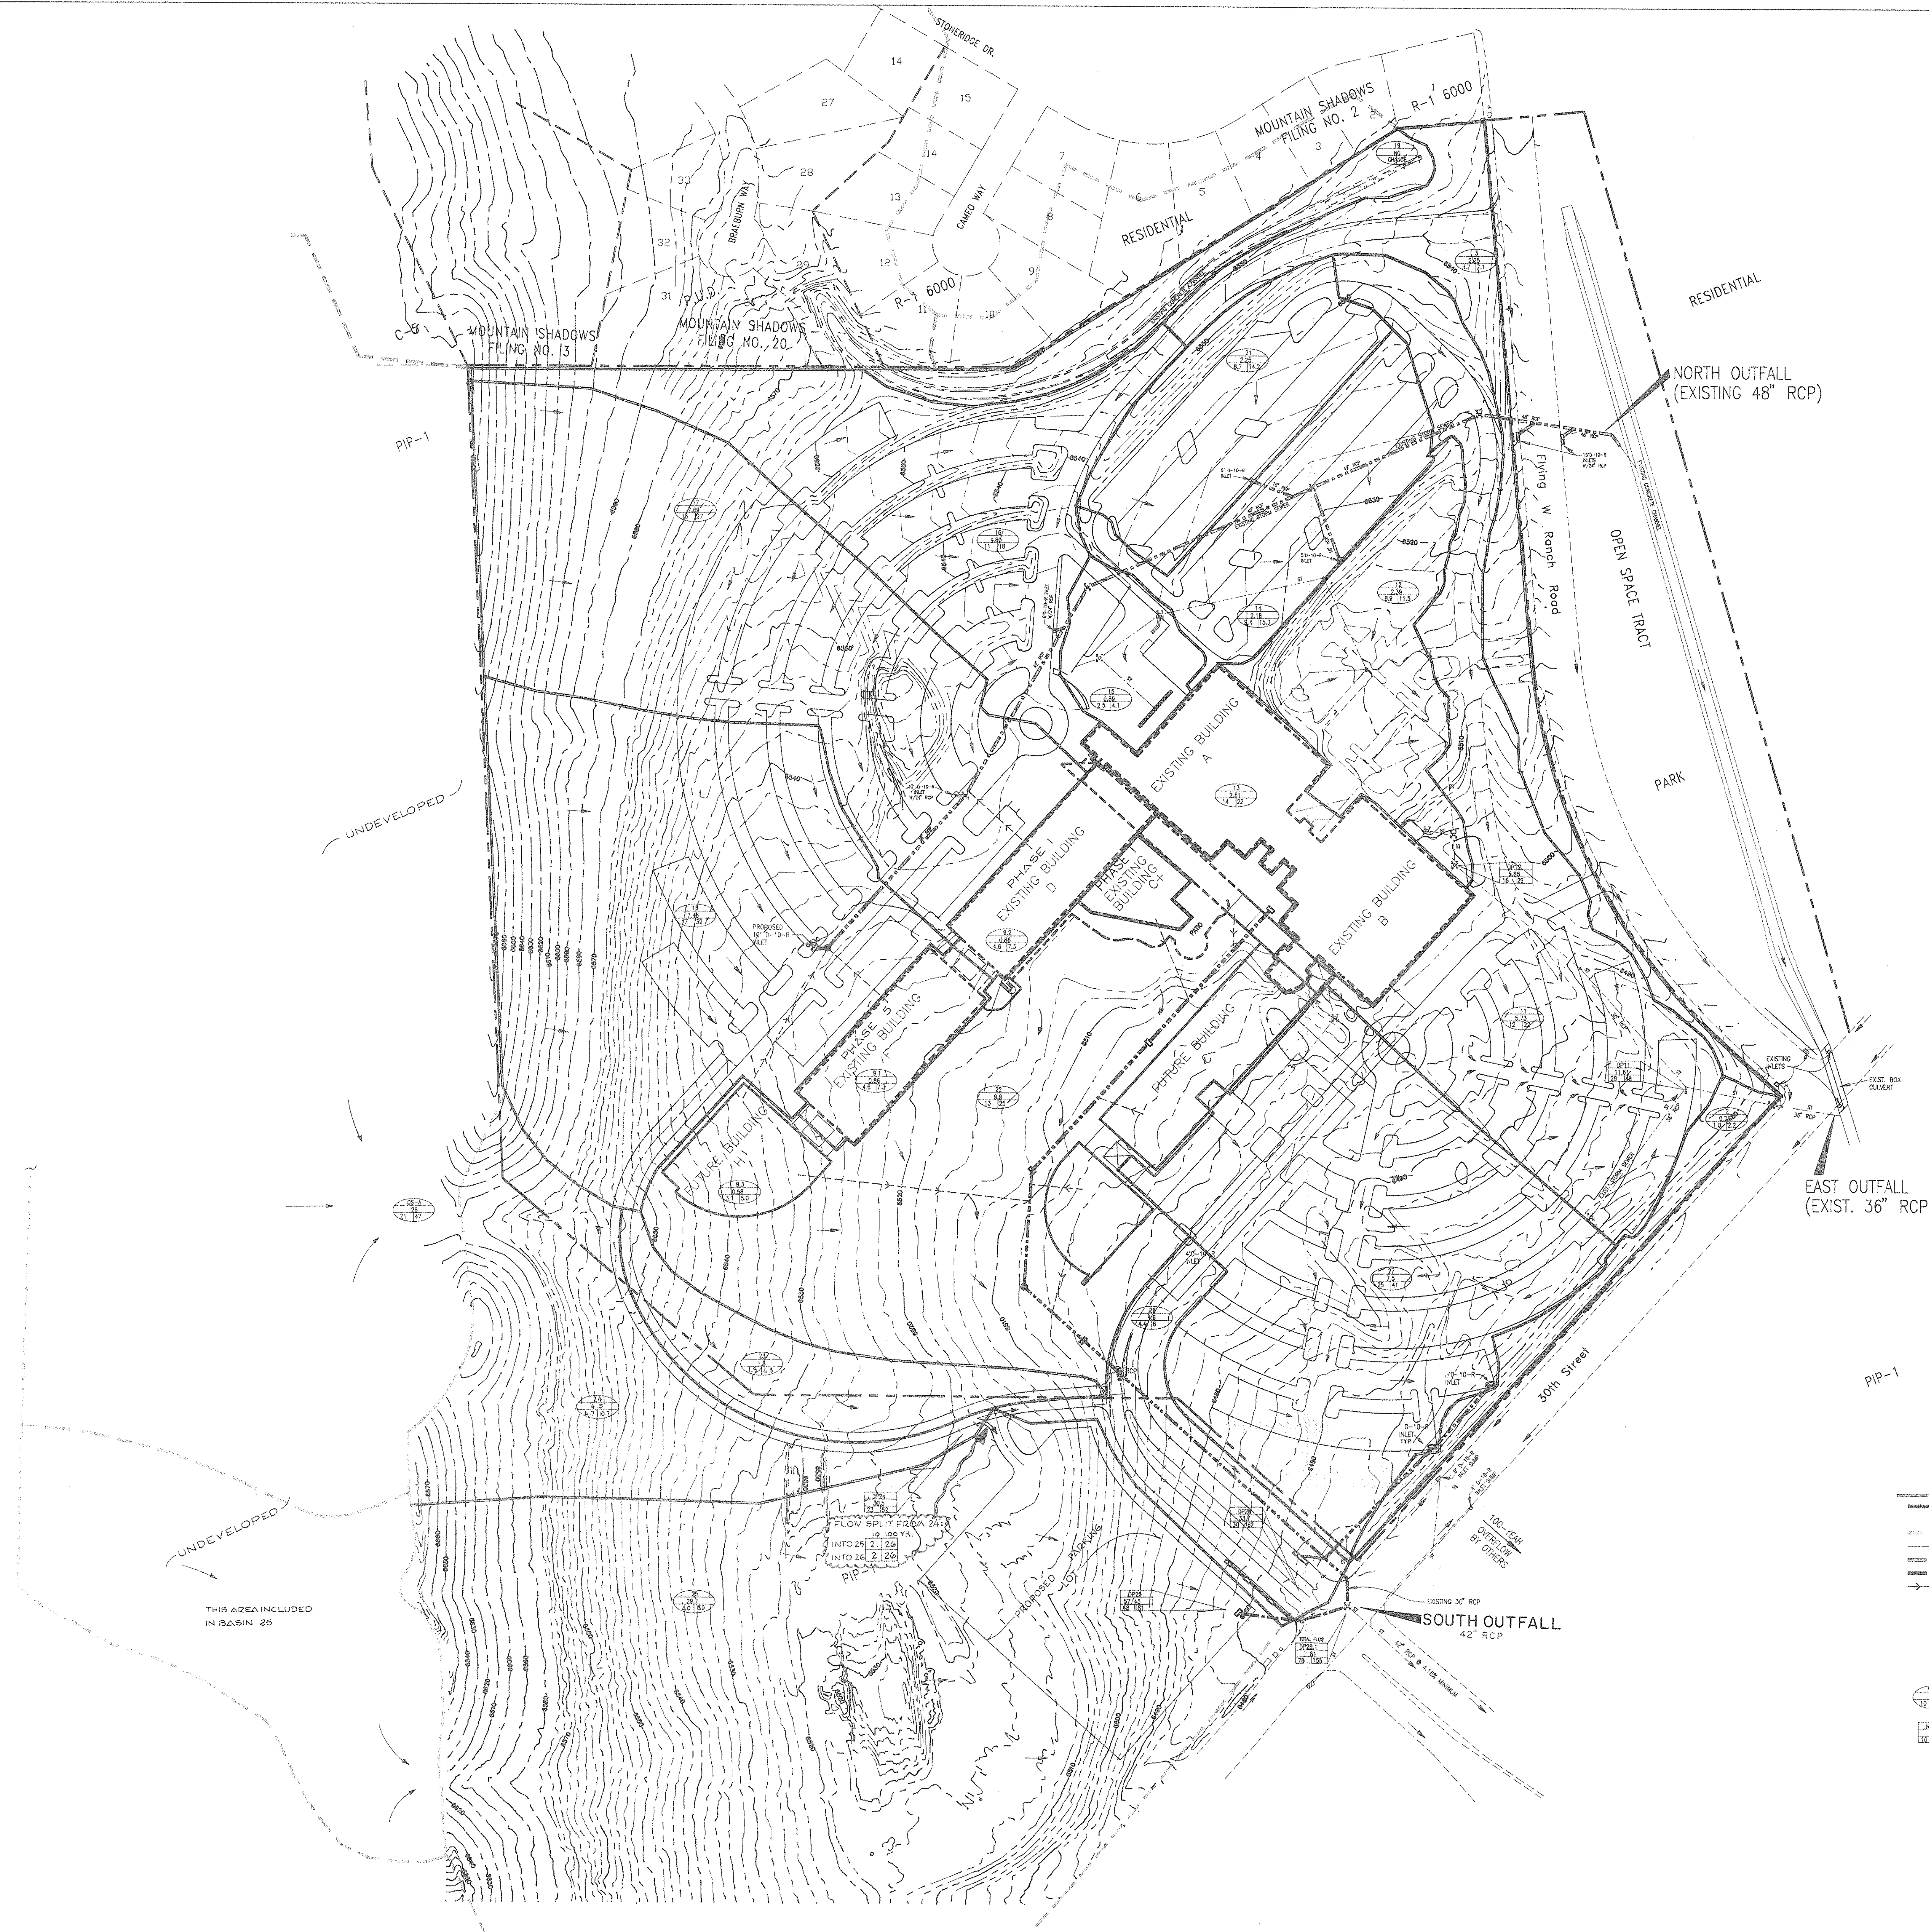


MCI

MASTER DEVELOPMENT DRAINAGE PLAN

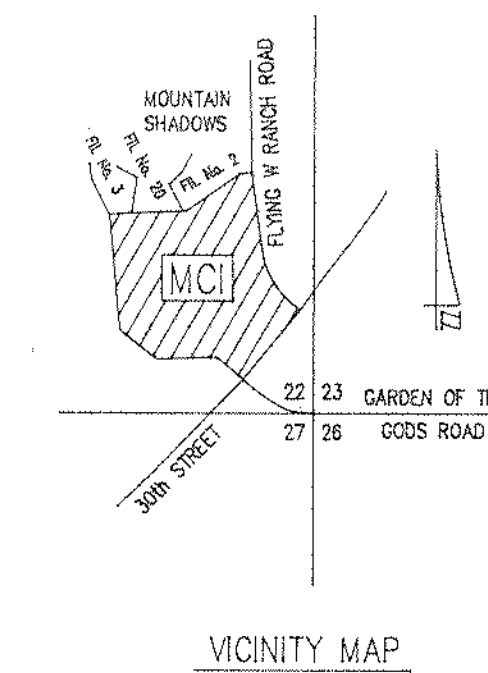

LEGEND

—	DEVELOPED BASINS
—	SOIL TYPES
○	HISTORIC OFF-SITE BASINS
—	EXISTING STORM SEWER
—	NEW PHASE 1 STORM SEWER
—	PROPOSED STORM SEWER
—	PROPOSED ROOF DRAINS
—	PROPOSED STORM INLET
—	EXISTING 10' CONTOUR
—	EXISTING 2' CONTOUR
—	PROPOSED 10' CONTOUR
—	PROPOSED 2' CONTOUR
○	SUB-BASIN AREA (ACRES)
○	10 & 100 YEAR FLOW (CFS)
○	DESIGN POINT AREA (ACRES)
○	10 & 100 YEAR FLOW (CFS)
○	SOIL NUMBER
○	HYDROLOGIC GROUP

SCALE 1"=100'

FILE: MCI-MDDP2.D
DATE: 3-24-83

KLH ENGINEERING, INC.
ENGINEERS / SURVEYORS / PLANNERS
308-208 SUTTON LANE, COLORADO SPRINGS, COLORADO 80907 719-594-4200

MCI
MASTER DEVELOPMENT DRAINAGE PLAN

DATE: 3/30/83
DESIGNER: B.J.H.
SCALE: 1"=100'

DESIGN BY: B.J.H. 91-546-00
DRAWN BY: M.F.S.