
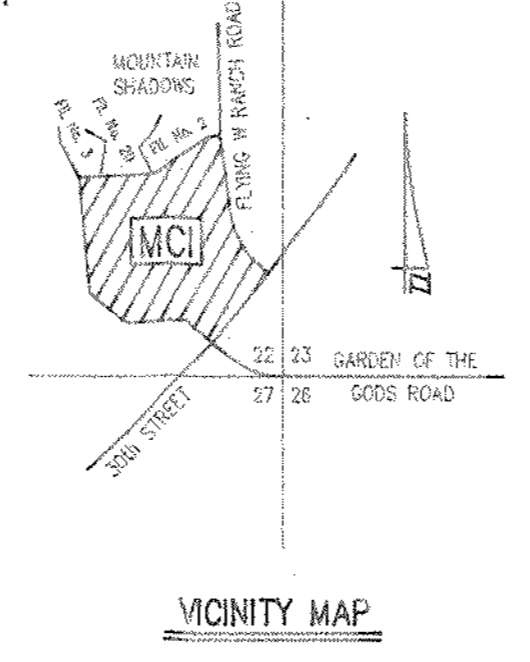


MCI

ORIGINAL DRAINAGE PLAN

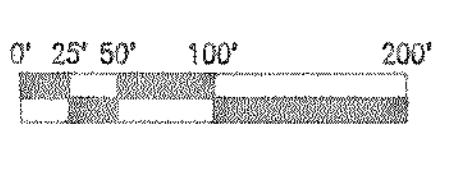

LEGEND

| | |
|--|--------------------------|
| | SUB-BASIN |
| | AREA (ACRES) |
| | 10 & 100 YEAR FLOW (CFS) |
| | DESIGN POINT |
| | AREA (ACRES) |
| | 10 & 100 YEAR FLOW (CFS) |
| | Basin Line |
| | EXISTING STORM SEWER |
| | SOIL TYPE |
| | SOIL NUMBER |

FILE: EBASIN.DWG
DATE: 8-28-91
PLOT: 8-28-91

KLH ENGINEERING, INC.
ENGINEERS / SURVEYORS / PLANNERS
205-205 SWITCH LANE, COLORADO SPRINGS, COLORADO 80907 719-584-4200

MCI ORIGINAL DRAINAGE PLAN

TITLE: EXHIBIT 1 DWG FILE: EBASIN
PROJECT: MCI ORIGINAL DRAINAGE PLAN DATE: 8/29/91 91-546-00
SCALE: 1"=100' DRAWN BY: DHI