
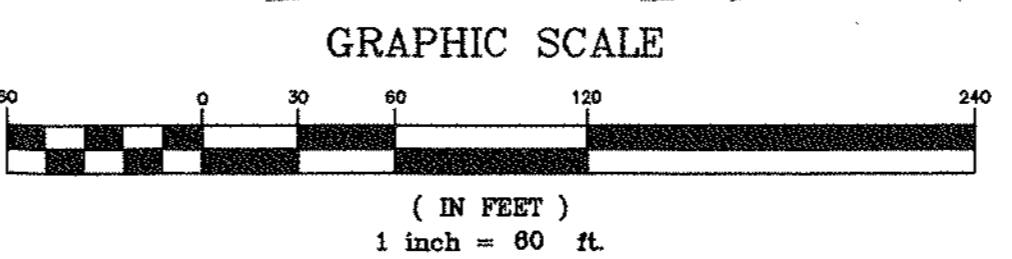


DESIGN PT. NO.	5 YEAR FLOW (CFS)	100 YEAR FLOW (CFS)
▲1	58.8	119.1
▲2	65.8	133.1
▲3	72.4	146.1
▲4	77.9	157.0
▲5	82.1	165.7
▲6	84.1	169.3
▲7	85.8	173.9
▲8	12.3	24.7

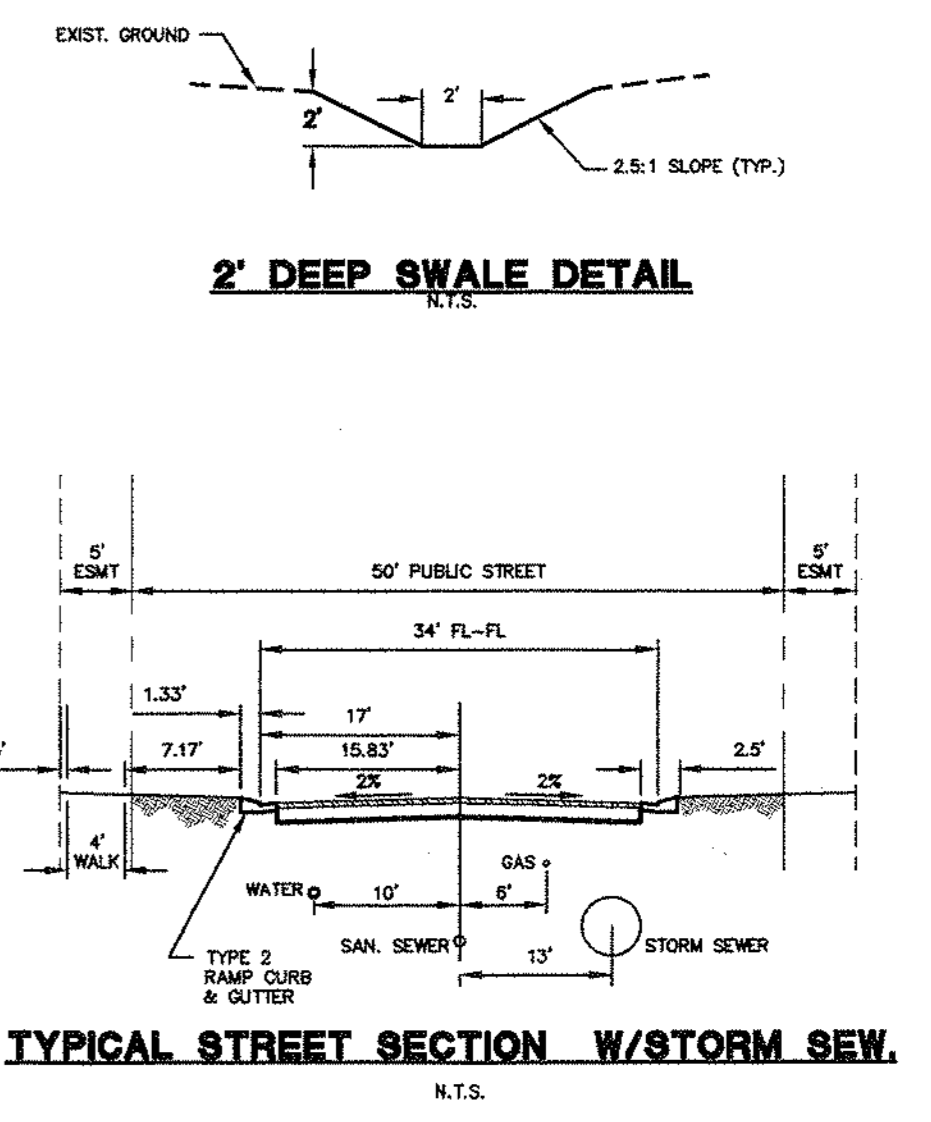

DESIGNED BY: MAB
 PROJECT ENGINEER: MAB
 PROJECT MANAGER: MAB
 DATE: 07/17/00
 SHEET NO.: 1 OF 1
 PLOT FILE NO.:
 DRAWN BY: MSP
 SCALE: 1" = 60'
 HORIZ. REF.: 11/21/00

PREPARED BY: **ADP**
 Associated Design Professionals, Inc.

1861 Austin Bluffs Parkway
 Suite 101
 Colorado Springs, CO 80918
 (719) 268-2212
 fax: (719) 268-5341

MILLER'S CROSSING SUBDIVISION
CITY OF COLORADO SPRINGS, COLORADO
MASTER DEVELOPMENT DRAINAGE PLAN

NO. DATE REVISION BY

SHEET
1 of 1

E:\LAND PROJECTS\981024\Info\Drainage\m113.dwg Thu Jul 20 14:11:51 2000