


DEVELOPED DRAINAGE BASIN TABLE

BASIN	AREA (Ac.)	Q <sub>5</sub> (CFS)	Q <sub>100</sub> (CFS)
OS-1	12.90	47.6	95.2
OS-2	3.32	7.6	19.3
OS-3	2.46	5.0	14.5
OS-4	10.20	5.5	9.6
OS-5	25.69	88.3	143.9
OS-6	2.37	6.2	12.9
OS-7	0.40	1.7	3.0
OS-8	0.64	2.3	4.5
OS-9	0.34	1.2	2.4
OS-10	2.92	8.8	18.7
OS-11	2.00	6.1	12.9
OS-12	2.83	8.7	18.3
I	2.44	7.6	16.2
II	4.42	12.1	27.7
III	2.10	6.0	13.8
IV	3.56	11.2	23.9
V	3.95	11.4	24.8
VI	1.66	5.3	11.3
VII	1.62	5.2	11.4
VIII	0.97	3.5	7.0
IX	2.69	7.7	16.1
X	4.29	11.7	24.4
XI	3.12	8.5	18.5
XII	1.27	4.6	9.1
XIII	12.41	28.7	61.6
XIV	2.75	7.7	16.6
XV	2.74	3.6	12.2
XVI	2.31	4.0	9.8
XVII	8.28	6.1	17.9
XVIII	4.11	10.9	23.0
XIX	5.93	16.2	33.7
XX	1.19	3.7	8.0
XXI	2.84	8.5	17.9
XXII-A	1.90	5.7	12.2
XXII-B	0.40	1.3	2.9
XXIII	3.36	9.2	19.6
XXIV	0.15	0.5	1.1
XXV-A	2.68	8.4	17.7
XXV-B	2.14	6.4	13.9
XXVI	2.57	7.6	16.2
XXVII	1.39	4.8	10.2
XXVIII	3.83	8.8	18.1
XXIX	1.51	4.9	10.0
XXX	0.82	2.0	4.4
XXXI	2.75	3.4	11.1

DESIGN POINT TABLE


BASIN	AREA (Ac.)	Q <sub>5</sub> (CFS)	Q <sub>100</sub> (CFS)
DP#1	49.22	127.4	267.6
DP#2	60.59	152.7	319.9
DP#3	15.16	27.0	67.2
DP#4	24.88	40.5	95.7
DP#5	85.47	159.2	376.4
DP#6	34.45	89.2	206.7
DP#7	133.26	225.7	563.4
OS-DP#1	27.63	84.7	185.0
OS-DP#2	3.75	10.2	20.7
OS-DP#3	29.44	78.3	164.6

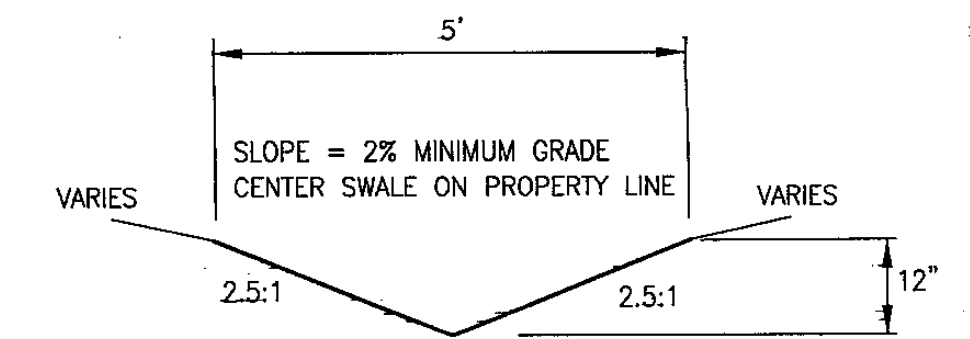

TYPICAL LOT LINE SWALE  
NO SCALE



1" = 100'

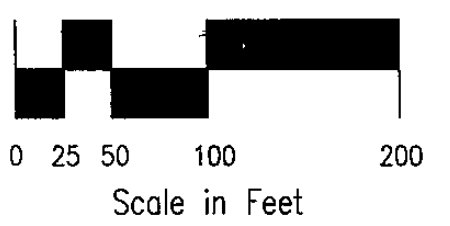

SHEET 1 OF 3

EXHIBIT 2

FILE: 02032DP2.DWG 9/20/03


**ROCKWELL MINCHOW**  
CONSULTANTS, INC.

ENGINEERING - SURVEYING  
1925 N. UNION BLVD., SUITE 200  
COLORADO SPRINGS, CO 80909  
(719) 475-2275 • FAX (719) 475-9223

TITLE : WESTCREEK AT WOLF RANCH  
DEVELOPED DRAINAGE PLAN

SCALE : 1"=100' DRAWN BY : KC 02-032

DATE : 9/20/03 CHECKED BY : KDR JOB NO.

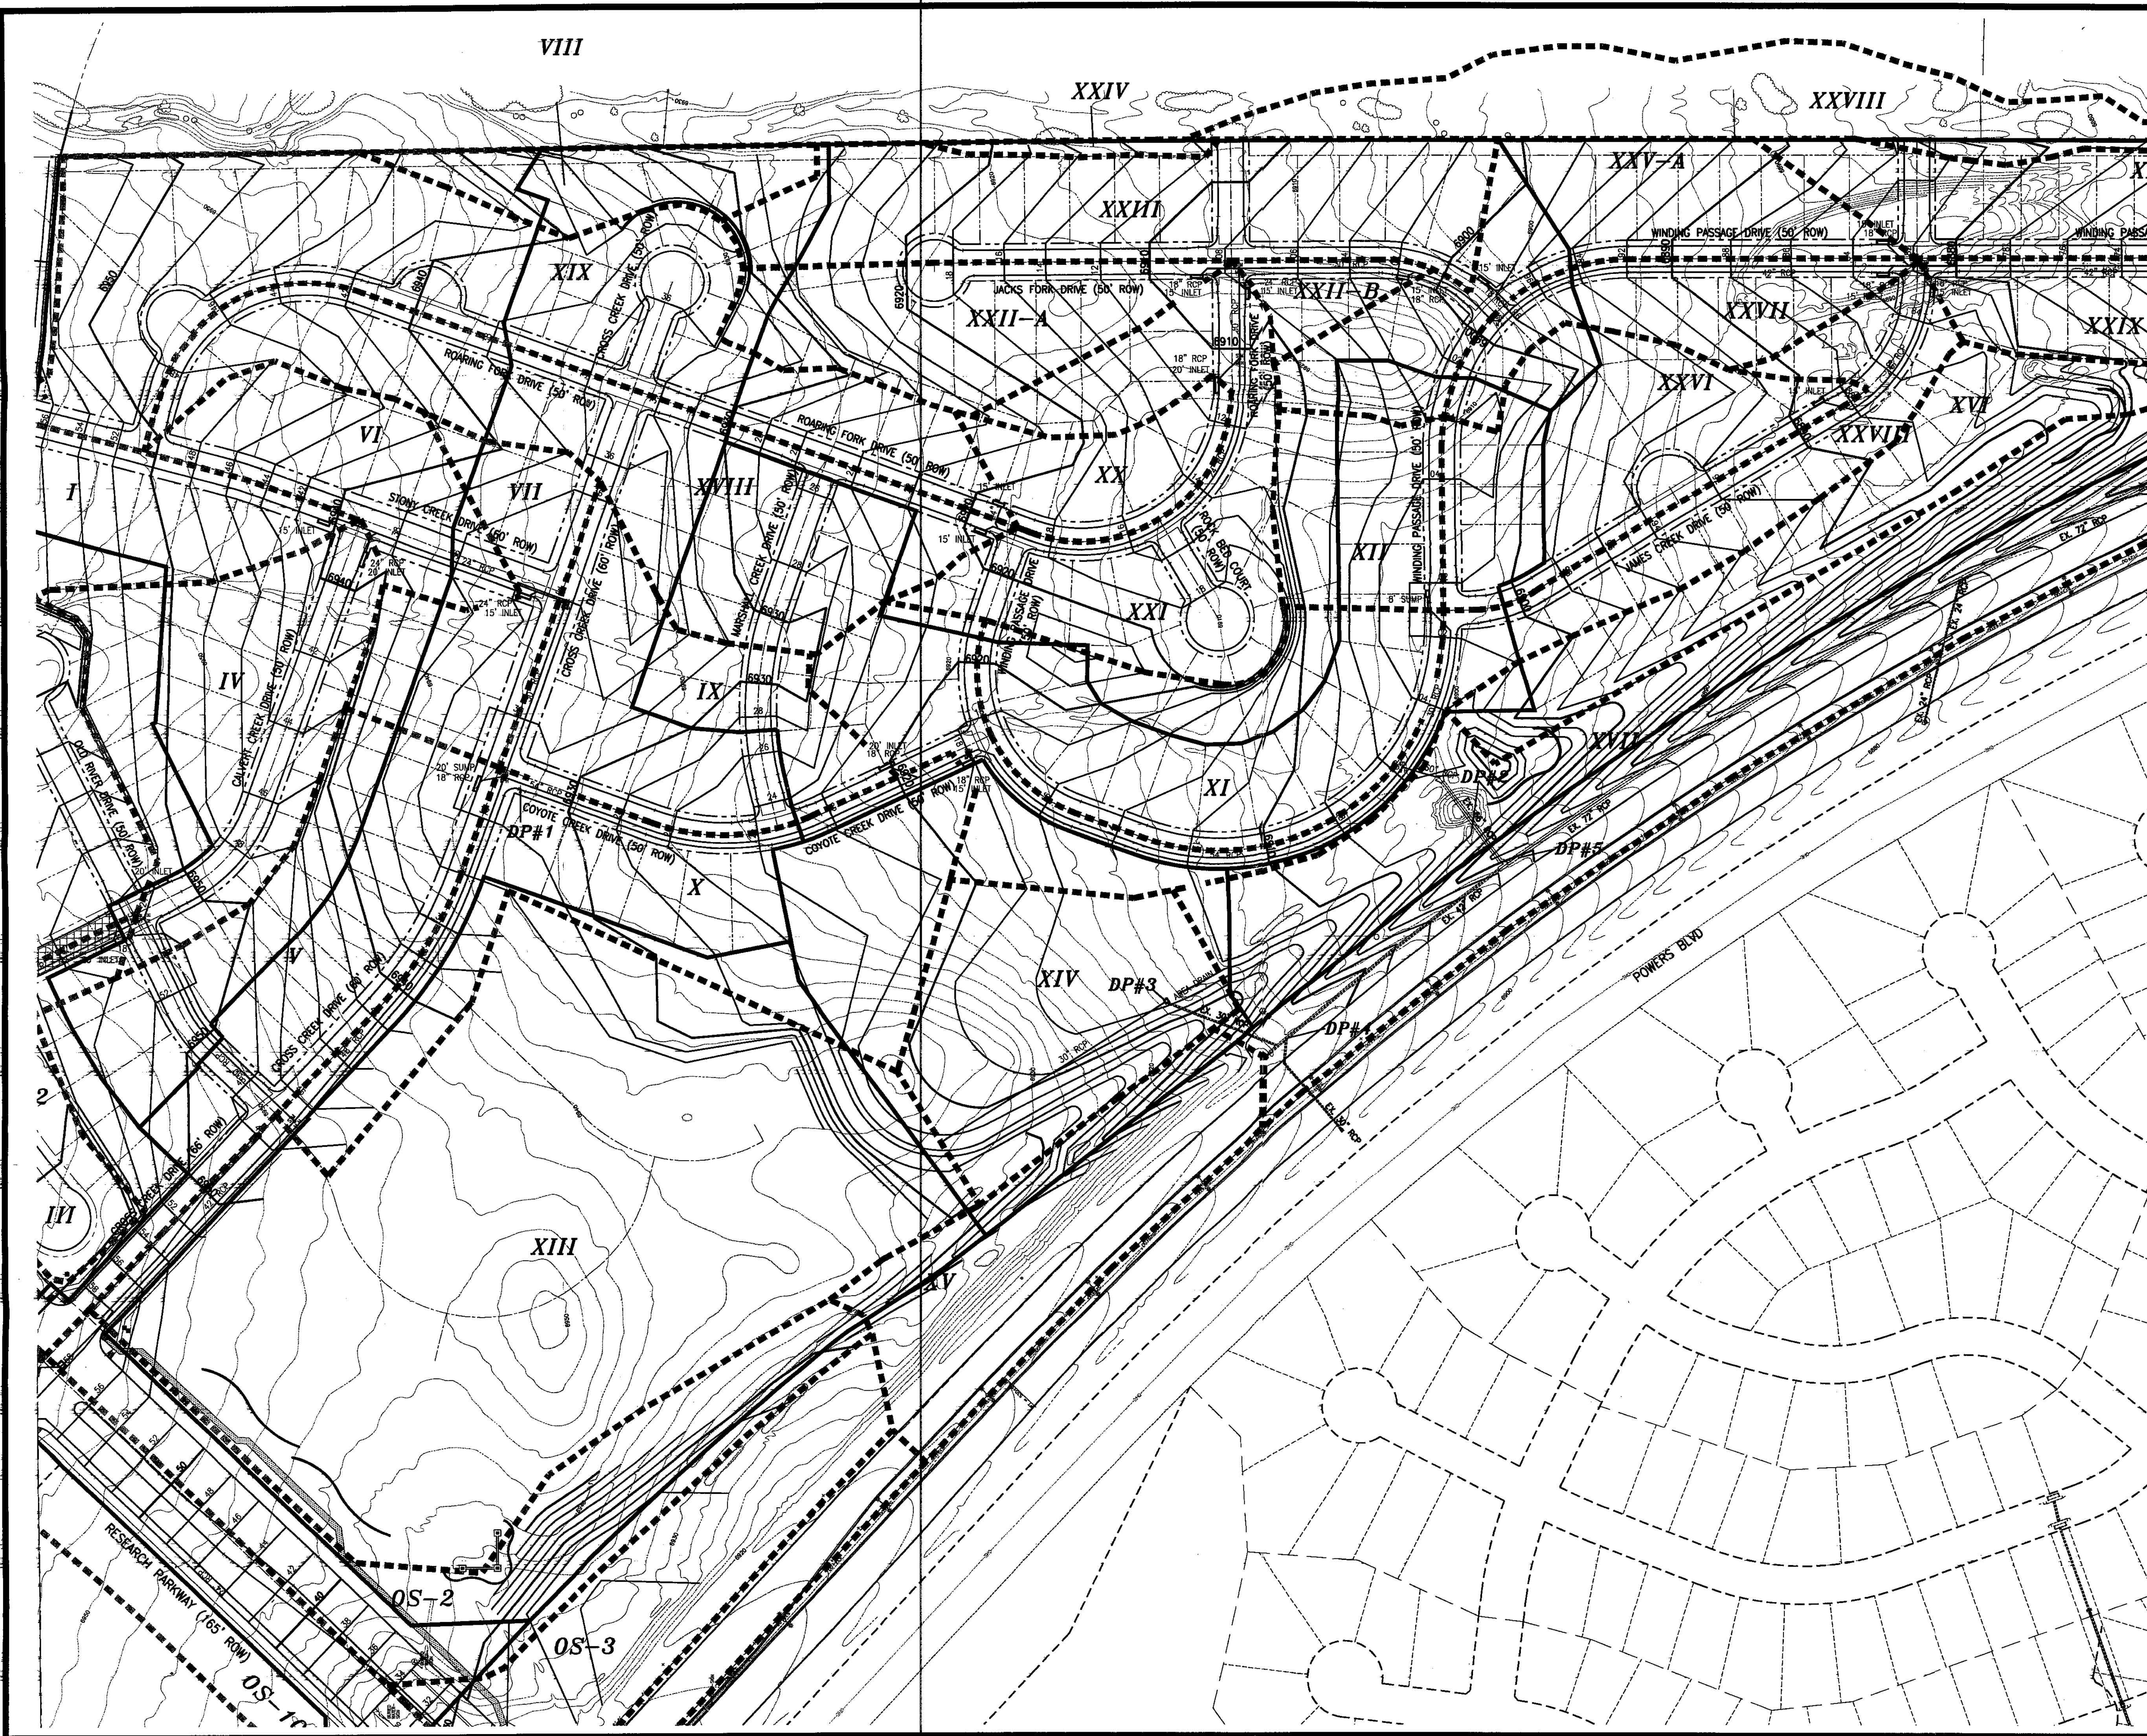


DEVELOPED DRAINAGE BASIN TABLE

BASIN	AREA (Ac.)	Q <sub>s</sub> (CFS)	Q <sub>100</sub> (CFS)
OS-1	12.90	47.6	95.2
OS-2	3.32	7.6	19.3
OS-3	2.46	5.0	14.5
OS-4	10.20	5.6	9.8
OS-5	25.69	68.3	143.9
OS-6	2.37	6.2	12.9
OS-7	0.40	1.7	3.0
OS-8	0.64	2.3	4.5
OS-9	0.34	1.2	2.4
OS-10	2.92	8.8	18.7
OS-11	2.00	6.1	12.9
OS-12	2.83	8.7	18.3
I	2.44	7.6	16.2
II	4.42	12.1	27.7
III	2.10	6.0	13.8
IV	3.56	11.2	23.9
V	3.98	11.4	24.8
VI	1.66	5.3	11.3
VII	1.62	5.2	11.4
VIII	0.97	3.5	7.0
IX	2.69	7.3	16.1
X	4.29	11.7	24.4
XI	3.12	8.5	18.5
XII	1.27	4.6	9.1
XIII	12.41	28.7	61.8
XIV	2.75	7.7	16.6
XV	2.74	3.6	12.2
XVI	2.31	4.0	9.8
XVII	8.28	6.1	17.9
XVIII	4.11	10.9	23.0
XIX	5.93	15.2	33.7
XX	1.19	3.7	8.0
XXI	2.84	8.5	17.9
XXII-A	1.90	5.7	12.2
XXII-B	0.40	1.3	2.8
XXIII	3.36	9.2	19.6
XXIV	0.15	0.5	1.1
XXV-A	2.66	8.4	17.7
XXV-B	2.14	6.4	13.9
XXVI	2.57	7.6	16.2
XXVII	1.59	4.8	10.2
XXVIII	3.83	8.8	18.1
XXIX	1.51	4.9	10.0
XXX	0.62	2.0	4.4
XXXI	2.75	3.4	11.1

DESIGN POINT TABLE

BASIN	AREA (Ac.)	Q <sub>s</sub> (CFS)	Q <sub>100</sub> (CFS)
DP#1	49.22	127.4	267.6
DP#2	60.59	152.7	319.9
DP#3	15.16	27.0	67.2
DP#4	24.88	40.5	95.7
DP#5	85.47	159.2	376.4
DP#6	34.45	89.2	206.7
DP#7	133.26	225.7	583.4
OS-DP#1	27.63	84.7	185.0
OS-DP#2	3.75	10.2	20.7
OS-DP#3	29.44	78.3	164.6

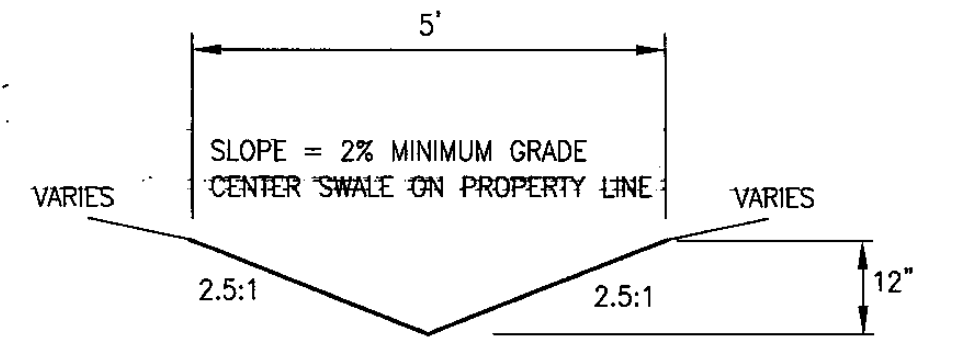

TYPICAL LOT LINE SWALE  
NO SCALE



1" = 100'




SHEET 2 OF 3 EXHIBIT 2  
FILE: 02032DP2.DWG 9/20/03

**ROCKWELL MINCHOW**  
CONSULTANTS, INC.

ENGINEERING • SURVEYING  
1955 N. UNION BLVD., SUITE 200  
COLORADO SPRINGS, CO 80909  
(719) 475-2575 • FAX (719) 475-9223

TITLE: WESTCREEK AT WOLF RANCH  
DEVELOPED DRAINAGE PLAN

SCALE: 1"=100' DRAWN BY: KC 02-032  
DATE: 9/20/03 CHECKED BY: KDR JOB NO.

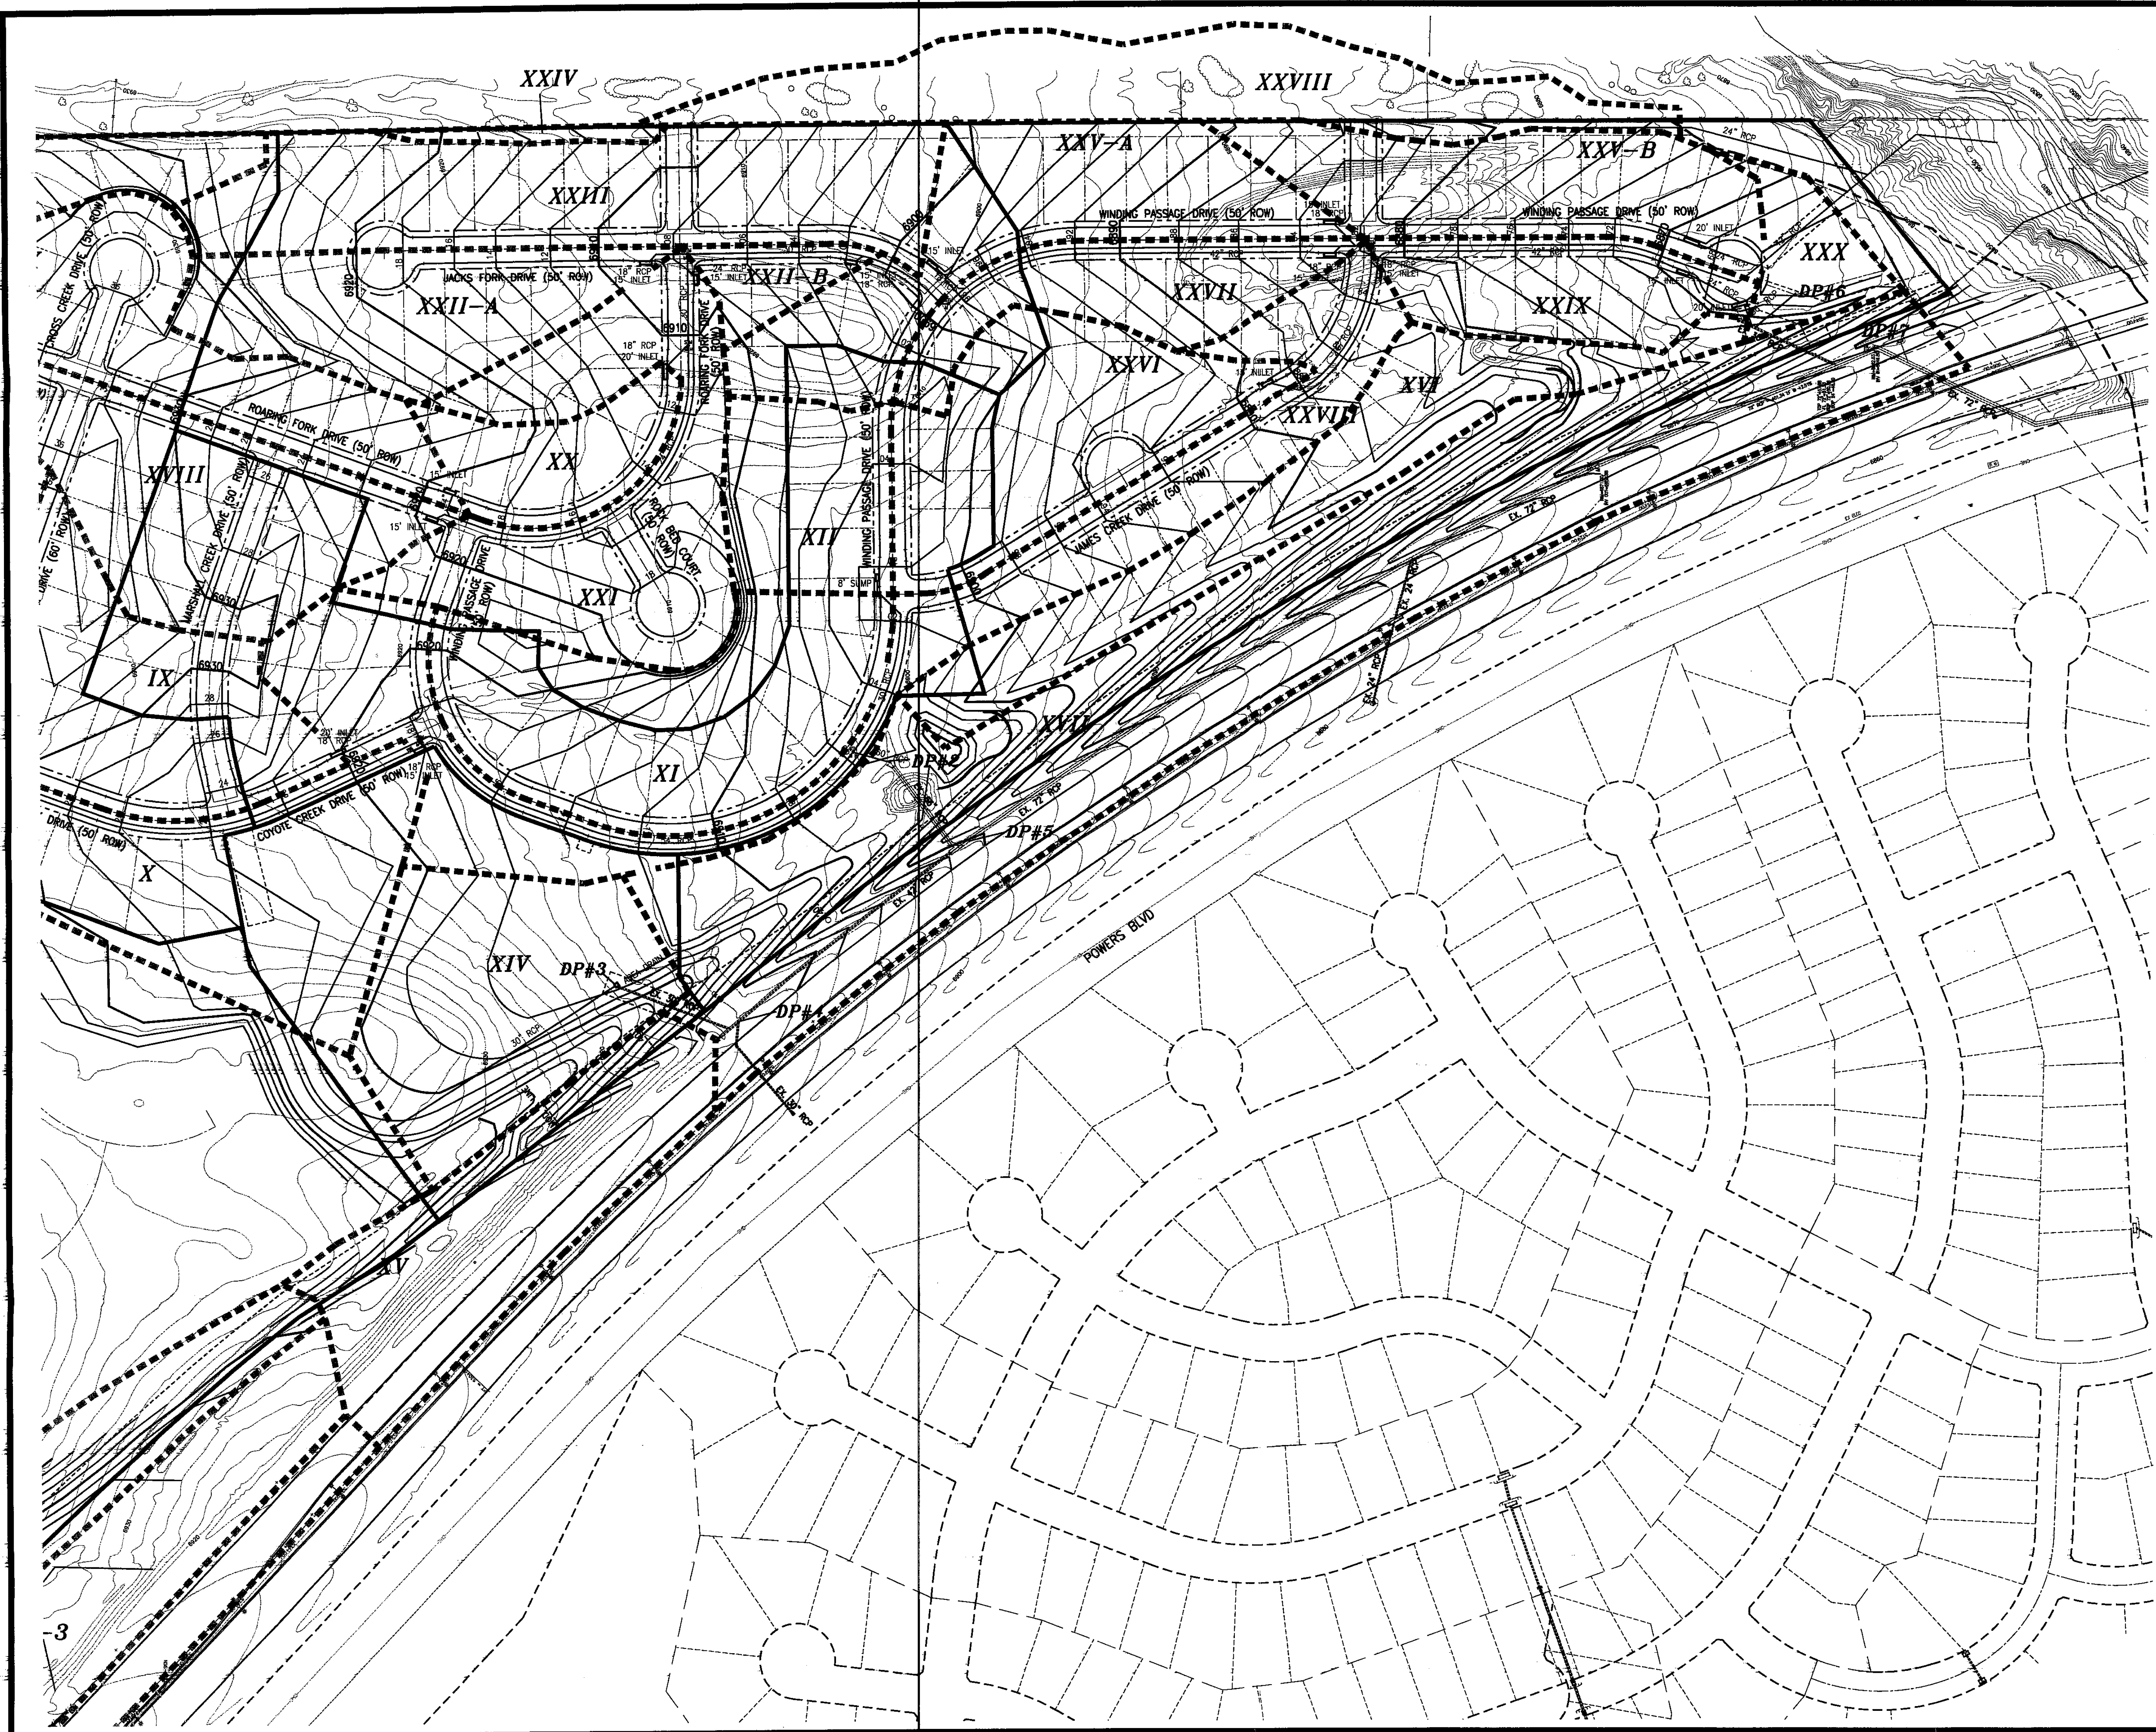


DEVELOPED DRAINAGE BASIN TABLE

BASIN	AREA (Ac.)	Q <sub>s</sub> (CFS)	Q <sub>100</sub> (CFS)
OS-1	12.90	47.6	95.2
OS-2	3.32	7.6	19.3
OS-3	2.46	5.0	14.5
OS-4	10.20	5.6	9.6
OS-5	25.89	68.3	143.9
OS-6	2.37	6.2	12.9
OS-7	0.40	1.7	3.0
OS-8	0.64	2.3	4.5
OS-9	0.34	1.2	2.4
OS-10	2.92	8.8	18.7
OS-11	2.00	6.1	12.9
OS-12	2.83	8.7	18.3
I	2.44	7.6	16.2
II	4.42	12.1	27.7
III	2.10	6.0	13.8
IV	3.36	11.2	23.9
V	3.98	11.4	24.8
VI	1.66	5.3	11.3
VII	1.62	5.2	11.4
VIII	0.97	3.5	7.0
IX	2.69	7.7	16.1
X	4.28	11.7	24.4
XI	3.12	8.5	18.5
XII	1.27	4.6	9.1
XIII	12.41	28.7	61.6
XIV	2.75	2.7	9.6
XV	2.74	3.6	12.2
XVI	2.31	4.0	9.8
XVII	8.28	6.1	17.9
XVIII	4.11	10.9	23.0
XIX	5.93	16.2	33.7
XX	1.19	3.7	8.0
XXI	2.84	8.5	17.9
XXII-A	1.90	5.7	12.2
XXII-B	0.40	1.3	2.9
XXIII	3.36	9.2	19.6
XXIV	0.15	0.5	1.1
XXV-A	2.66	8.4	17.7
XXV-B	2.14	6.4	13.9
XXVI	2.57	7.6	16.2
XXVII	1.39	4.8	10.2
XXVIII	3.83	8.8	18.1
XXIX	1.51	4.9	10.0
XXX	0.62	2.0	4.4
XXXI	2.75	3.4	11.1

DESIGN POINT TABLE


BASIN	AREA (Ac.)	Q <sub>s</sub> (CFS)	Q <sub>100</sub> (CFS)
DP#1	49.22	127.4	267.6
DP#2	60.59	152.7	319.9
DP#3	15.16	27.0	67.2
DP#4	24.88	40.5	95.7
DP#5	85.41	159.2	378.4
DP#6	34.45	88.2	206.7
DP#7	133.28	225.7	563.4
OS-DP#1	27.63	84.7	185.0
OS-DP#2	3.75	10.2	20.7
OS-DP#3	29.44	78.3	164.6

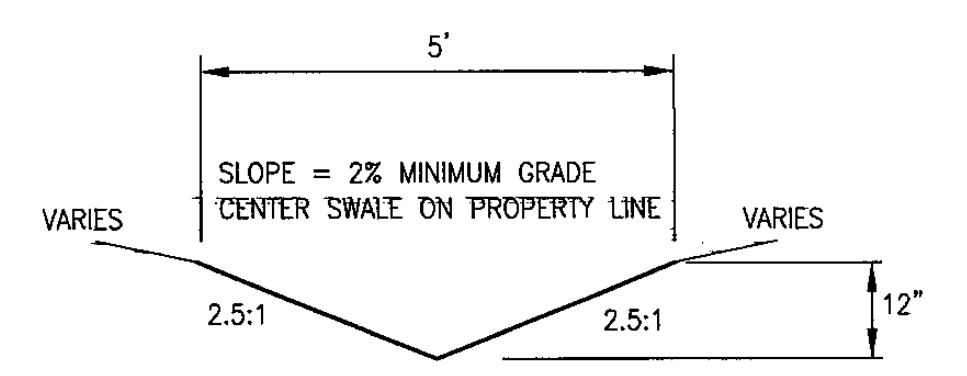

TYPICAL LOT LINE SWALE  
NO SCALE



1" = 100'

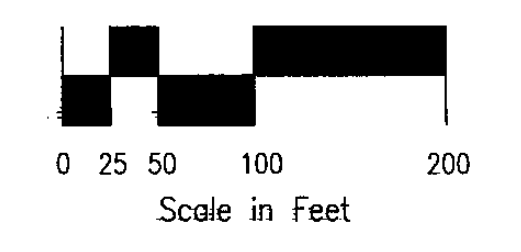

SHEET 3 OF 3 EXHIBIT 2  
FILE: 02032DP2.DWG 9/20/03

**ROCKWELL MINCHOW**  
CONSULTANTS, INC.

ENGINEERING - SURVEYING  
1555 N. BROWN BLVD., SUITE 200  
COLORADO SPRINGS, CO 80909  
(719) 475-2575 • FAX (719) 475-9223

TITLE: WESTCREEK AT WOLF RANCH  
DEVELOPED DRAINAGE PLAN

SCALE: 1"=100' DRAWN BY: KC  
DATE: 9/20/03 CHECKED BY: KDR

02-032  
JOB NO.